


ATTACHMENT C

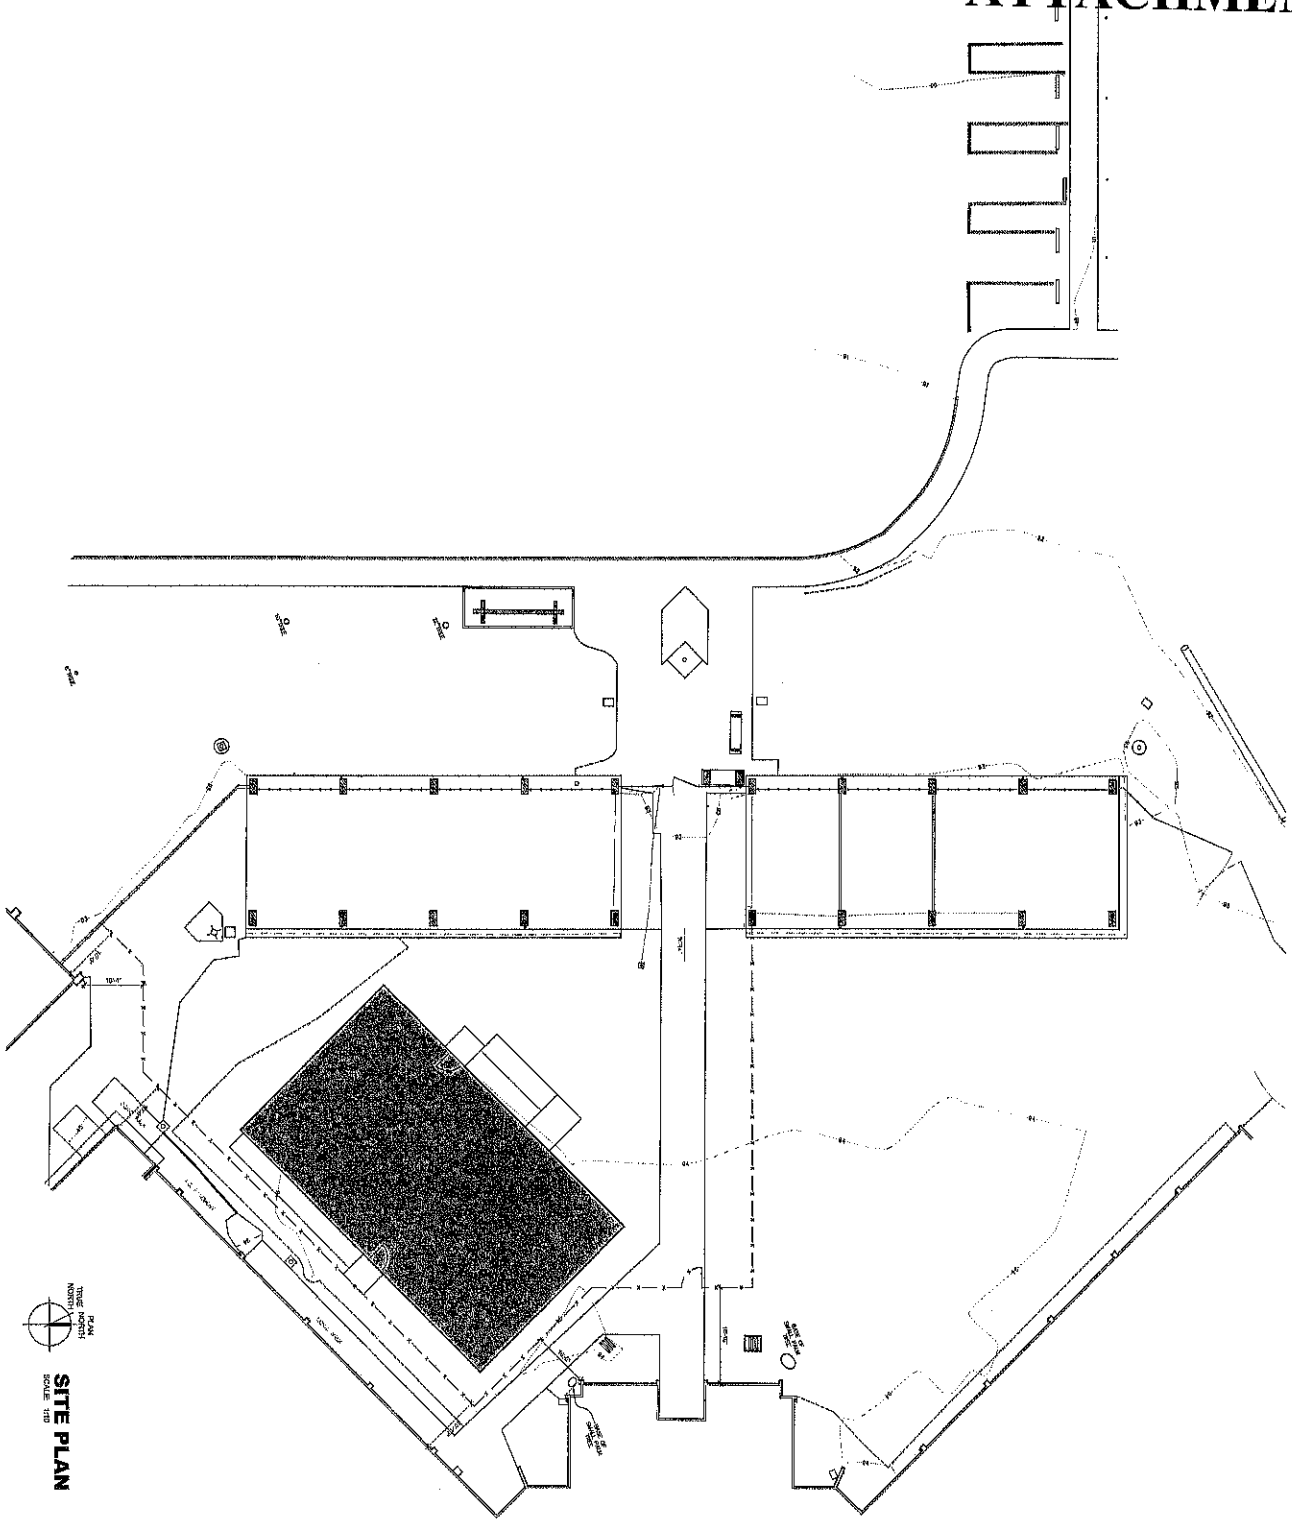

SITE PLAN
SCALE: 1/8" = 1'-0"

SITE PLAN
SHEET NO: **A100**
FILE NAME: SCHEMATIC

PROJECT NAME	241138
PROJECT DATE	11/2/2014
ISSUED DATE	11/2/2014
DESIGNED BY	RTS
CHECKED BY	RTS
DATE	
SCALE	
PROJECT NO.	
PROJECT NAME	
PROJECT DATE	
ISSUED DATE	
DESIGNED BY	
CHECKED BY	
DATE	
SCALE	
PROJECT NO.	

**RE-ENTRY RESOURCE CENTER
MONTEREY COUNTY SHERIFF'S DEPT.**

MONTEREY COUNTY OFFICE OF PUBLIC WORKS
ADDRESS
ADDRESS

AP.N.: AP.N.

WR&D
WILSON RAYBURN & DESIGN
ARCHITECTS
2305 GARDEN ROAD, SUITE 200
MONTEREY, CALIFORNIA 95033
PHONE: 831.344.4444
FAX: 831.344.4444
WWW.WR&D.COM

60