


**Exhibit "B" to Radio Communication Site Lease Agreement**

**SITE PLAN**

**(See attached)**

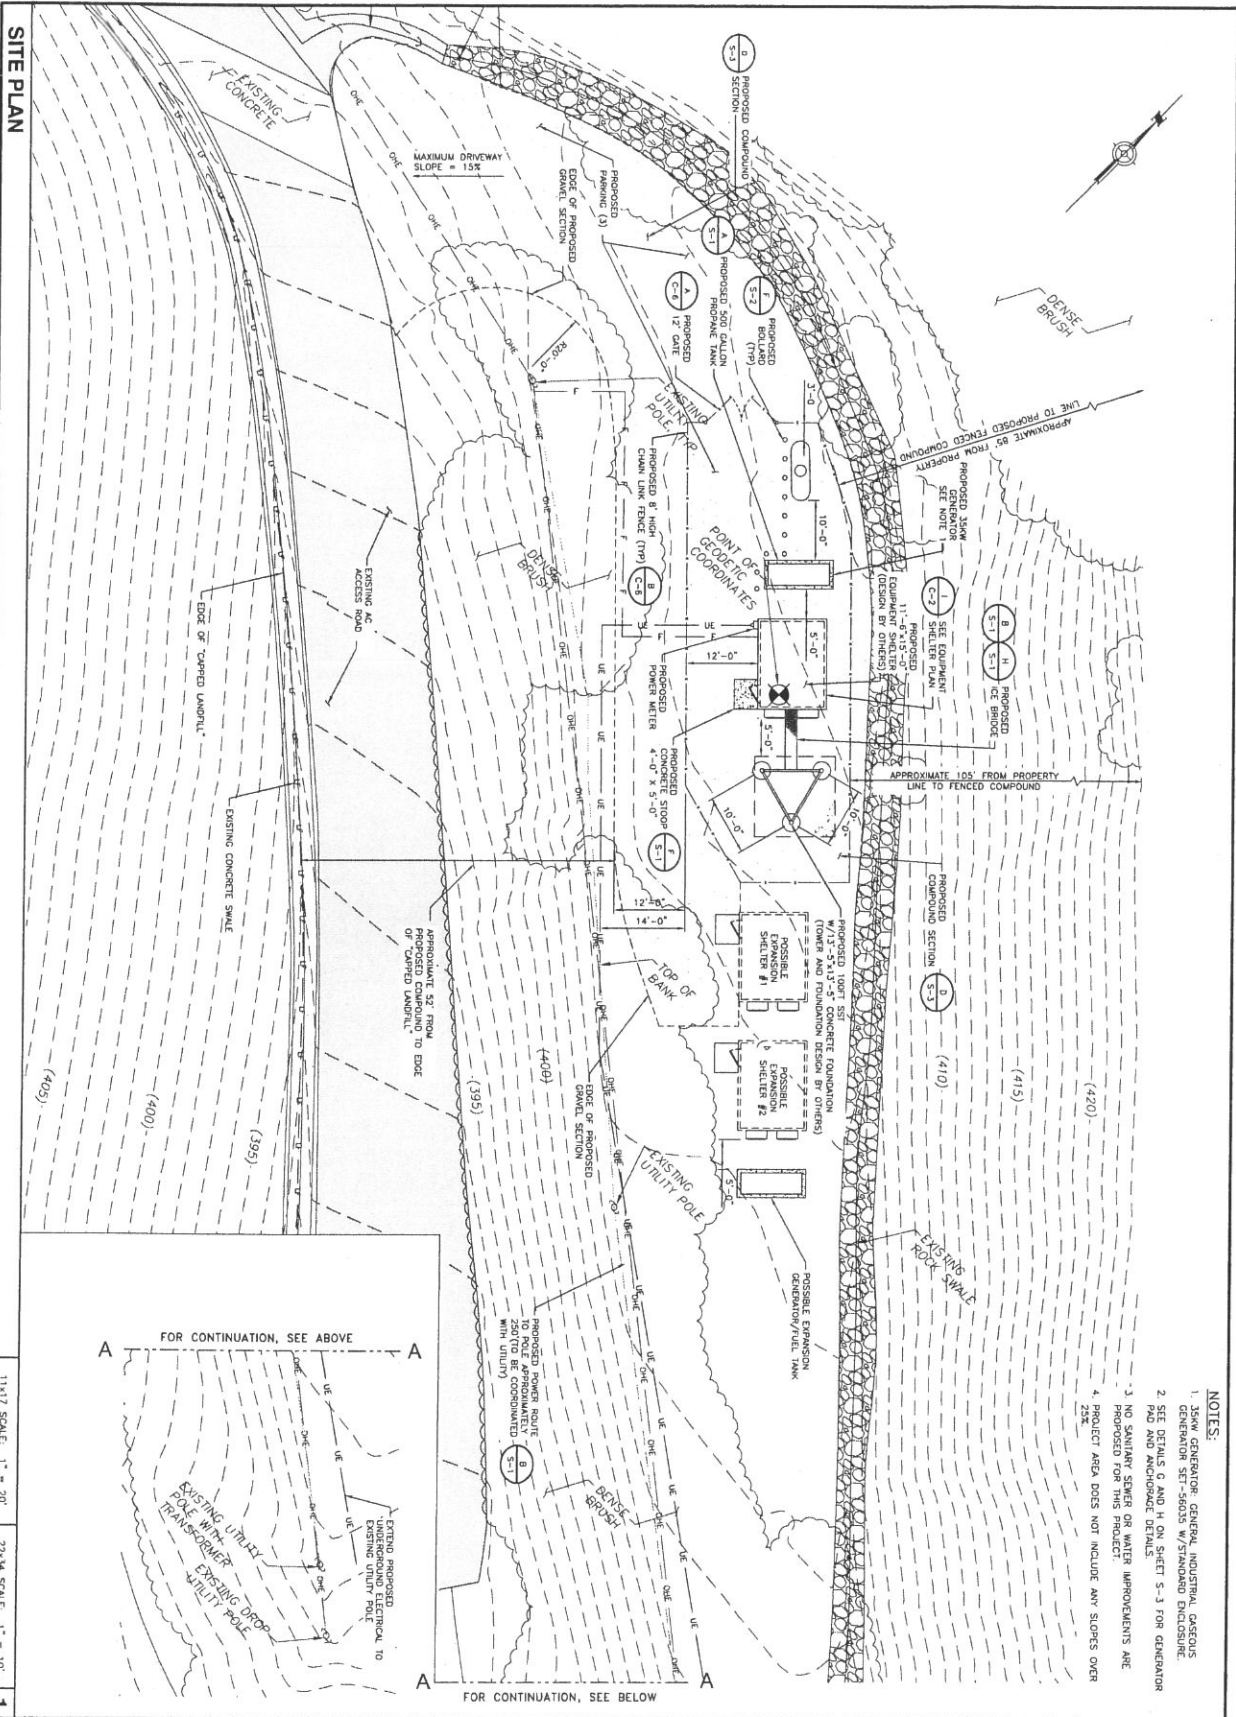

- NOTES:
1. 500W GENERATOR- GENERAL INDUSTRIAL GASOLINE GENERATOR SET-56055 W/STANDARD ENCLOSURE.
  2. SEE DETAILS G AND H ON SHEET S-3 FOR GENERATOR PAD AND ANCHORAGE DETAILS.
  3. NO SANITARY SEWER OR WATER IMPROVEMENTS ARE PROPOSED FOR THIS PROJECT.
  4. PROJECT AREA DOES NOT INCLUDE ANY SLOPES OVER 25%.

11x17 SCALE: 1" = 20'  
 22x34 SCALE: 1" = 10'

<p>SHEET TITLE <b>SITE PLAN</b></p> <p>SHEET NUMBER <b>C-1</b></p>	<p>LEWIS ROAD LANDFILL          MONTEREY COUNTY          1010 LEWIS RD          WATSONVILLE, CA 95076</p>	<p>PROJECT NO: 173683          DRAWN BY: NMB          CHECKED BY: BN</p>	<p><b>BLACK &amp; VEATCH</b></p> <p>5885 WILSONS ROAD, SUITE 700          WATSONVILLE, CA 95070          (503) 933-4400</p>	<p><b>HARRIS</b></p> <p>RF COMMUNICATIONS DIVISION          223 GERRISON ROAD PARKWAY          WATSONVILLE, CA 95070          (818) 934-4000</p>
----------------------------------------------------------------------------	-----------------------------------------------------------------------------------------------------------------------	----------------------------------------------------------------------------------	-------------------------------------------------------------------------------------------------------------------------------------	--------------------------------------------------------------------------------------------------------------------------------------------------------------